
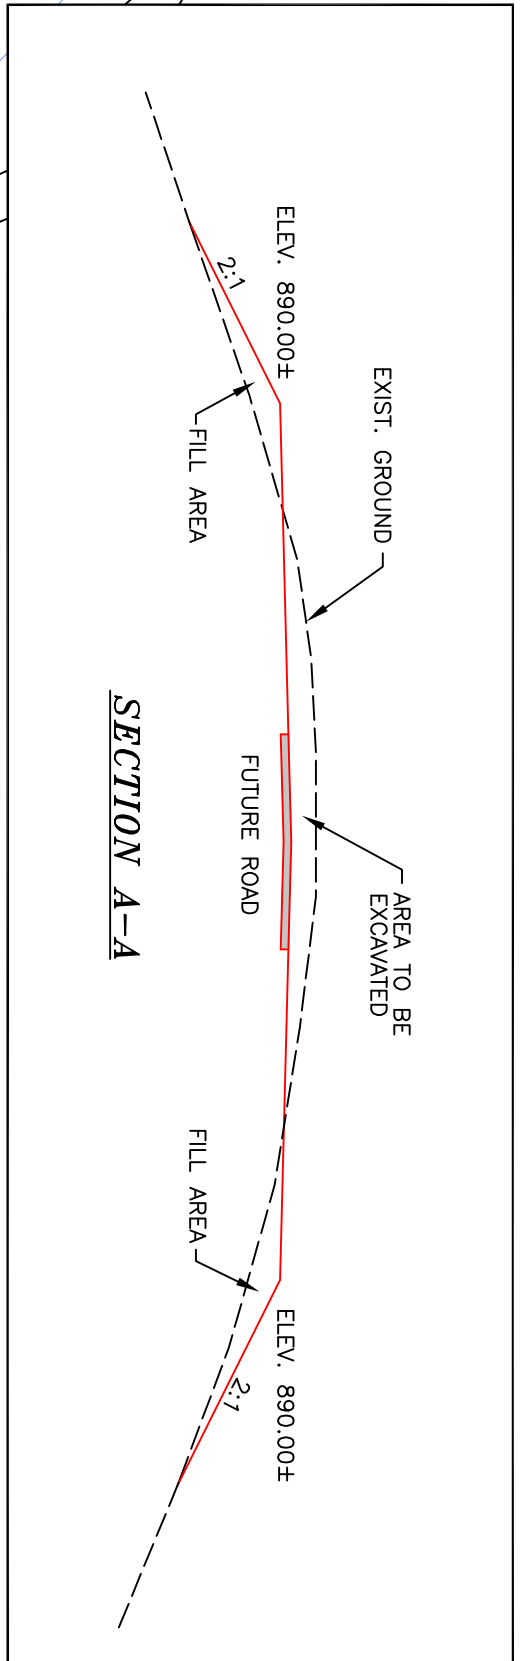


LEGEND

- PROPOSED PROPERTY LINE
- EXISTING PROPERTY LINE
- PROPOSED RIGHT OF WAY
- EXISTING RIGHT OF WAY
- PROPOSED CULVERT LOCATION
- DRAINAGE FLOW DIRECTION
- GRADING LIMITS

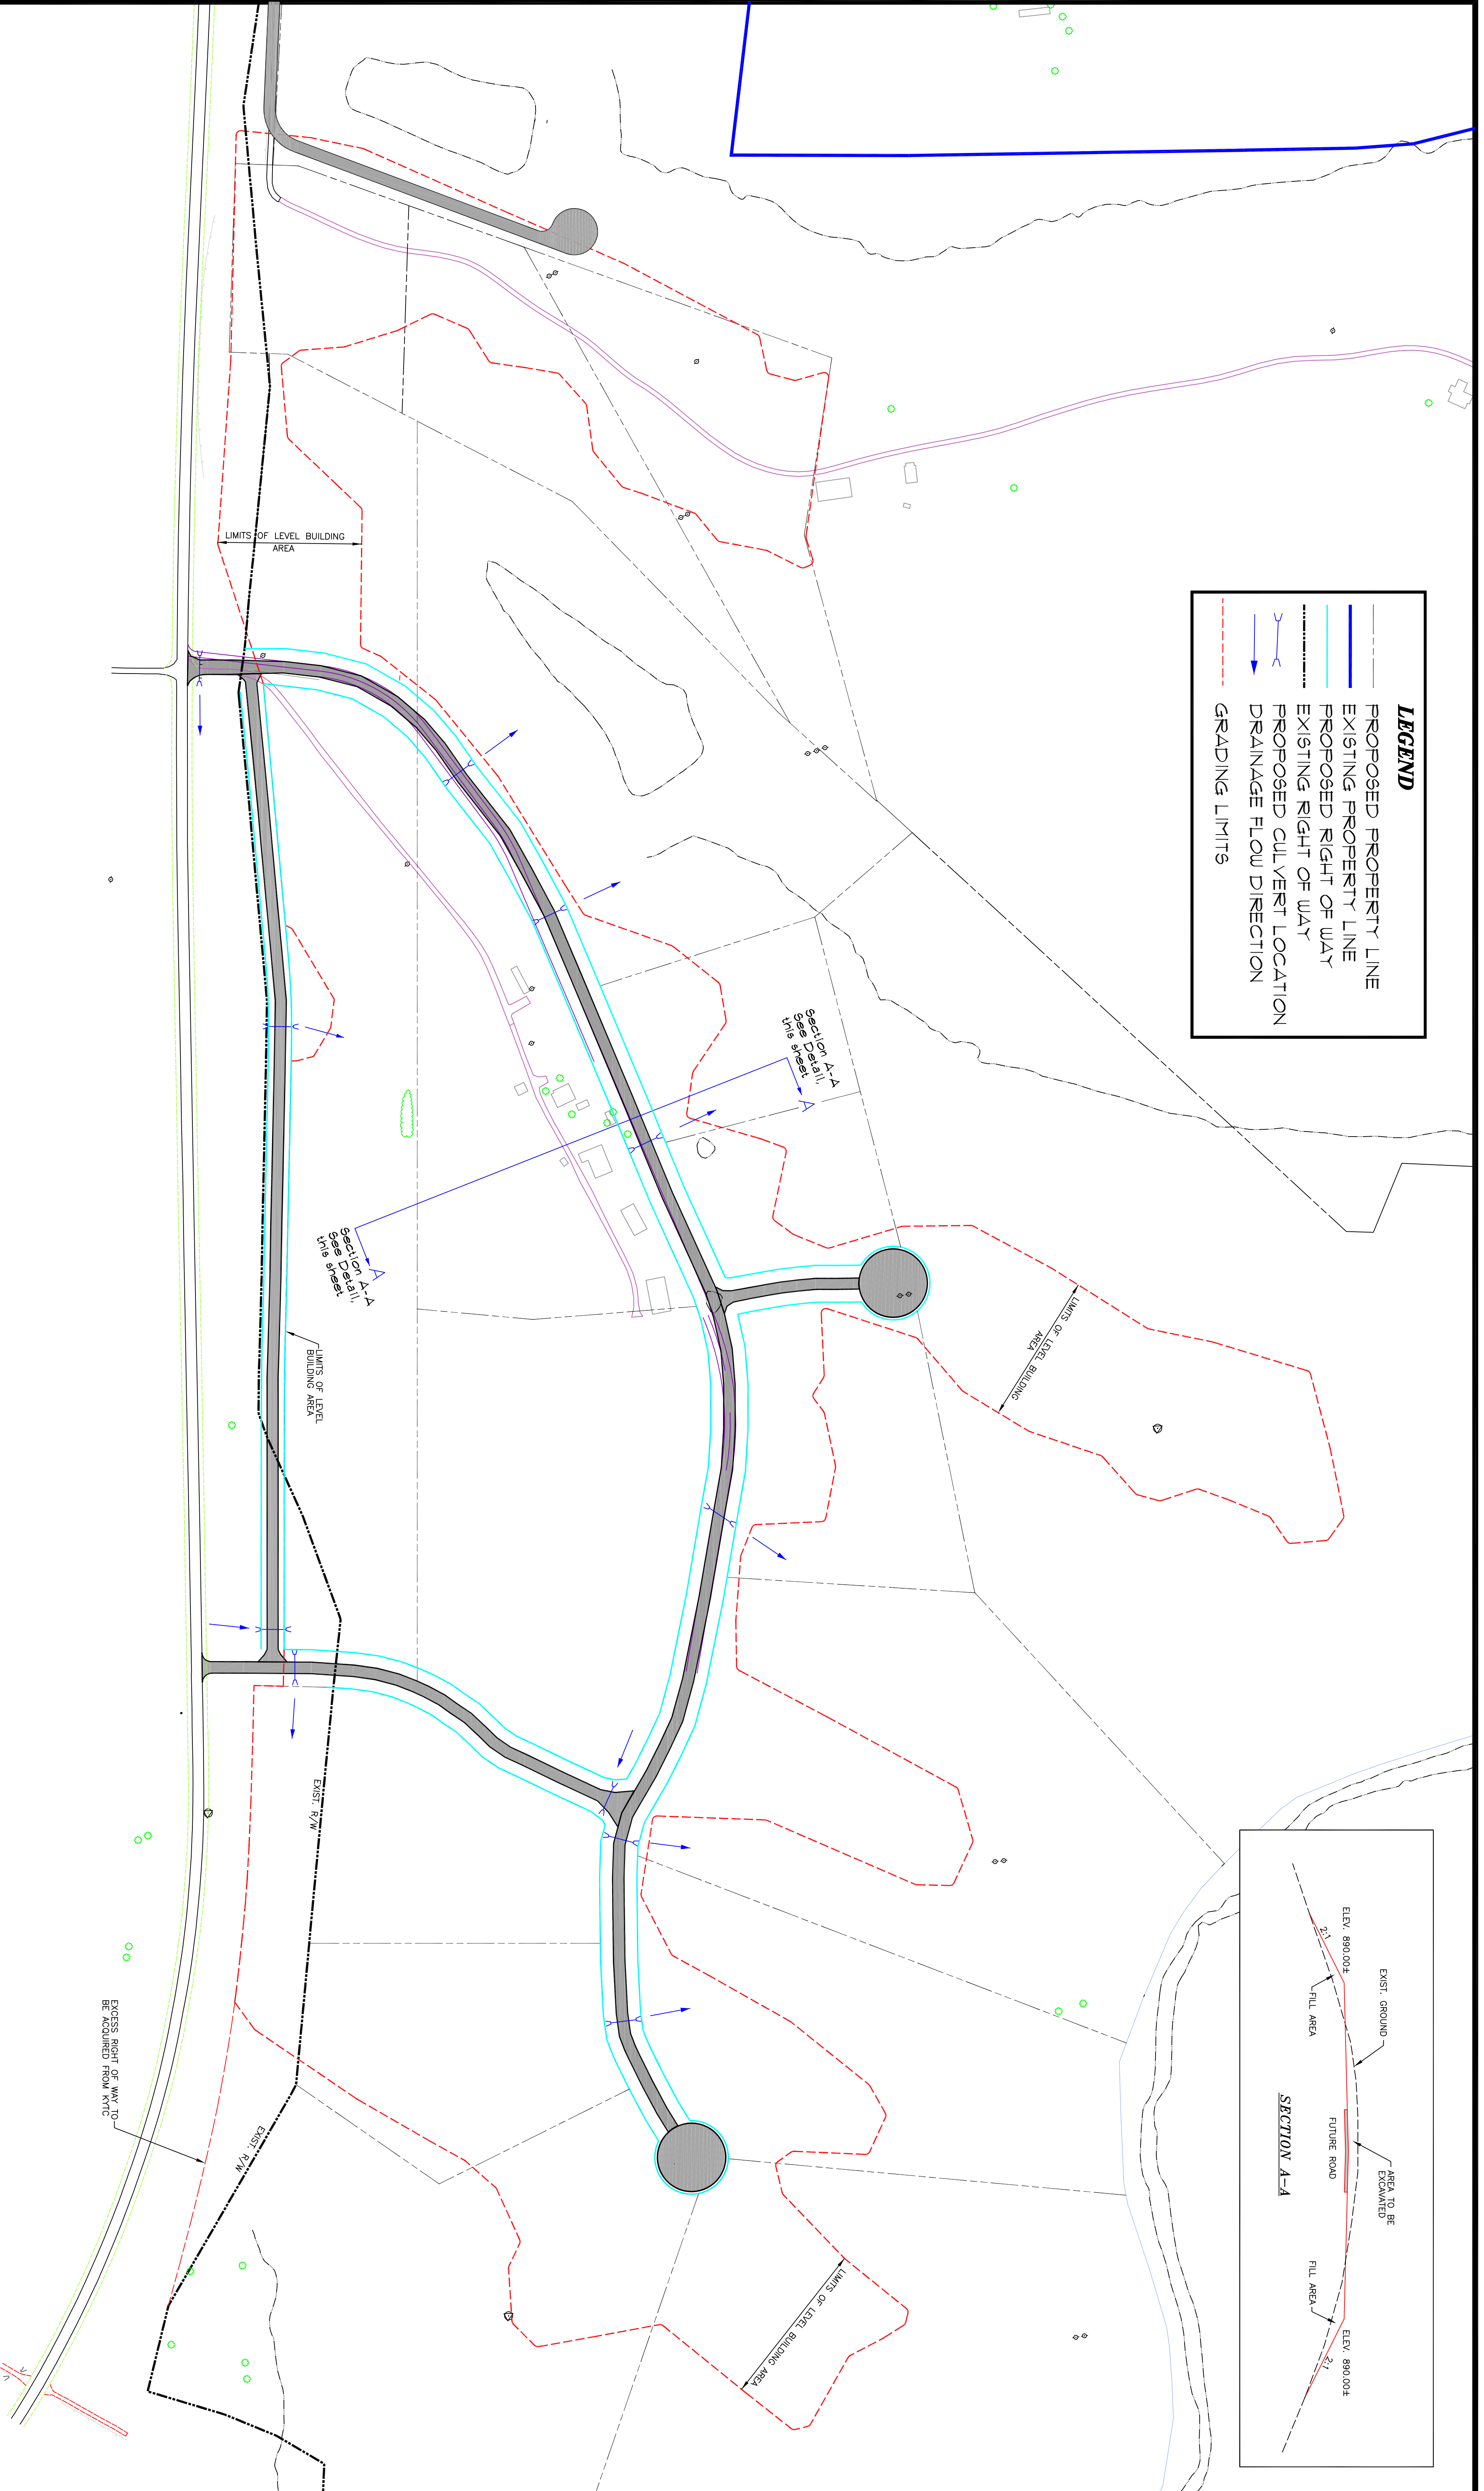

PROJECT: 412100		DATE: 02/08	
SCALE: 1" = 160'			
DESIGNED BY	JFG	DATE	02/08
DRAWN BY	SAB	DATE	02/08
CHECKED BY	JFG	DATE	02/08
RECORD DWS.			

HMB
 PROFESSIONAL ENGINEERS, INC.

3 HMB CIRCLE
 FRANKFORT, KENTUCKY
 (502) 635-3800
 (502) 635-9810 FAX

AUGUSTA/BROOKSVILLE BRACKEN COUNTY INDUSTRIAL DEVELOPMENT AUTHORITY BRACKEN COUNTY, KENTUCKY		SHEET 1 OF 1
BUILDING SITE PLAN & CONCEPTUAL DRAINAGE PLAN		

NO.	DATE	REVISIONS	CHK'D	APP'D	DATE